



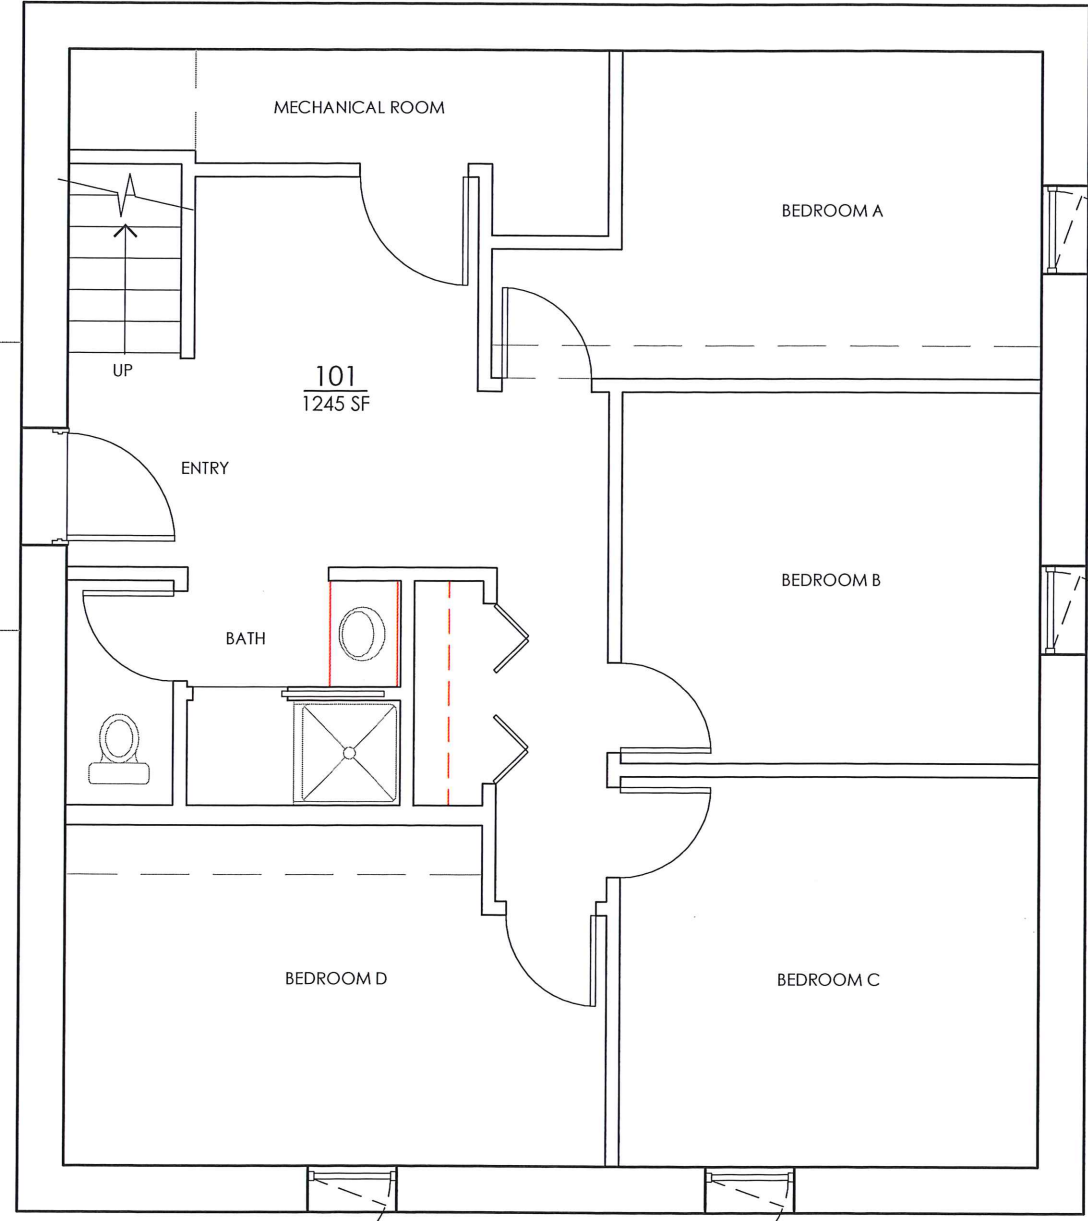

1st Floor

 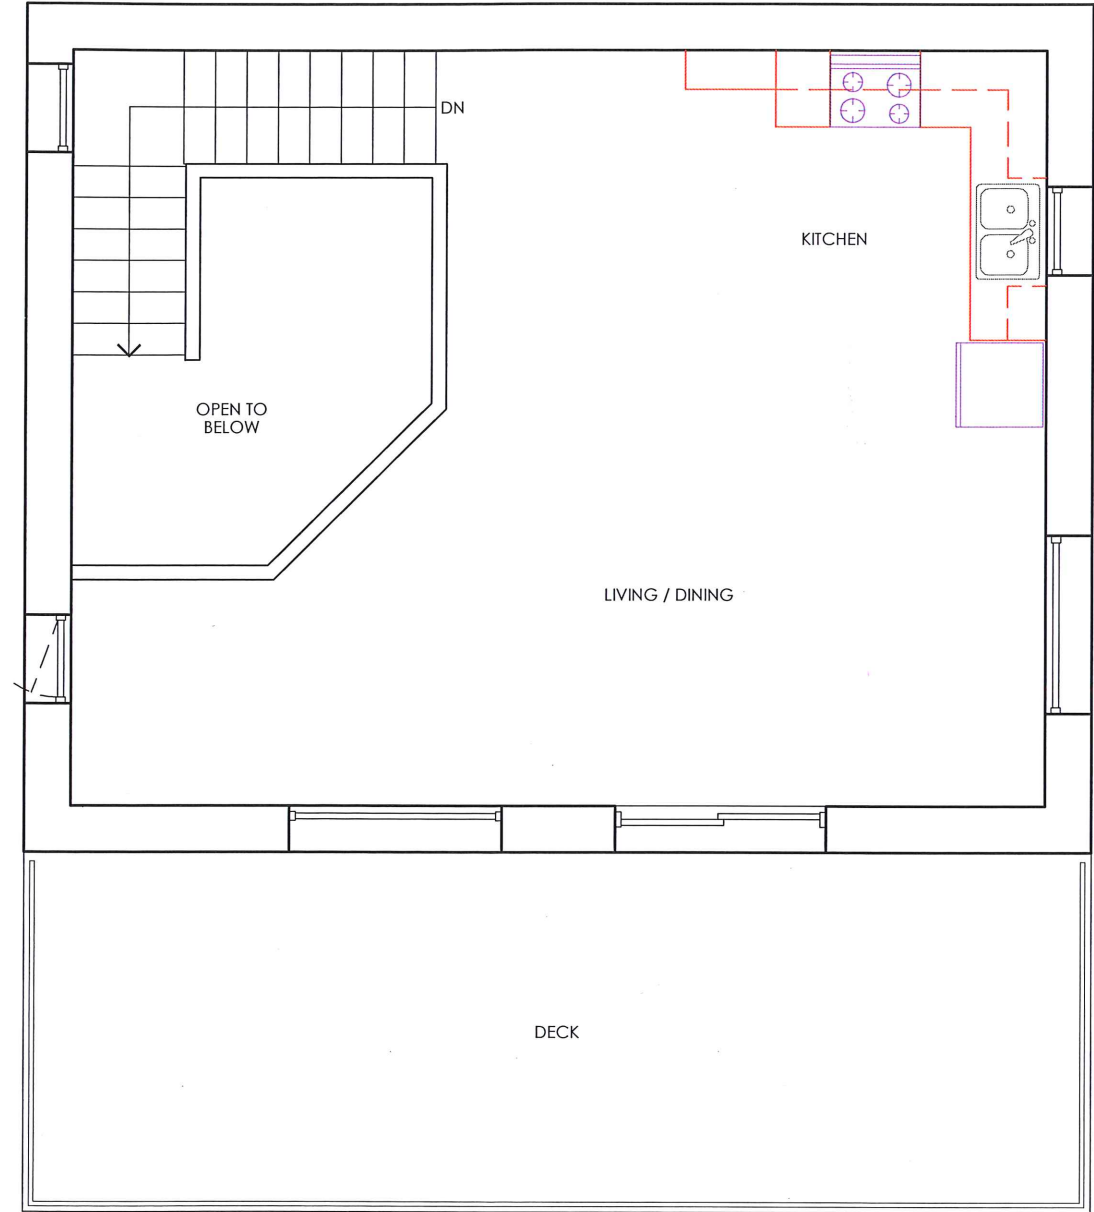


2nd Floor



Sustainable Student Housing Unit 2 FS441

SCALE: 3/16" = 1'-0" @ 11x17



FACILITIES SERVICES

DESIGN & CONSTRUCTION
P.O. BOX 758160
FAIRBANKS, AK 99775-8160
907-474-5999
907-474-7554 (fax)
www.uaf.edu/ddc



SHEET NO.

1

OF 1

Project Title:
FACILITIES INVENTORY - BLDG FS441
SUSTAINABLE STUDENT HOUSING UNIT 2

Sheet Title:
TAMARACK HOUSE

FIRST & SECOND FLOORS

Drawn:
CFP

Checked:

Date:
11 Sept 2012

Scale:
AS DISPLAYED

Project Number:
FS441

REVISIONS:

NO. DATE

1 9/28/12 A/MCAD Export

NOTES:

BY:

cfp